



PLOT SCALE: 1:1 EDIT DATE: 6/29/18 - 2:14 PM EDITED BY: MSCHULZE DRAWING FILE: O:\2017\01180\DRAWINGS\CIVIL\EXHIBITS\SITE LAYOUTS\2017.01180.CE MASTER UTILITY.DWG

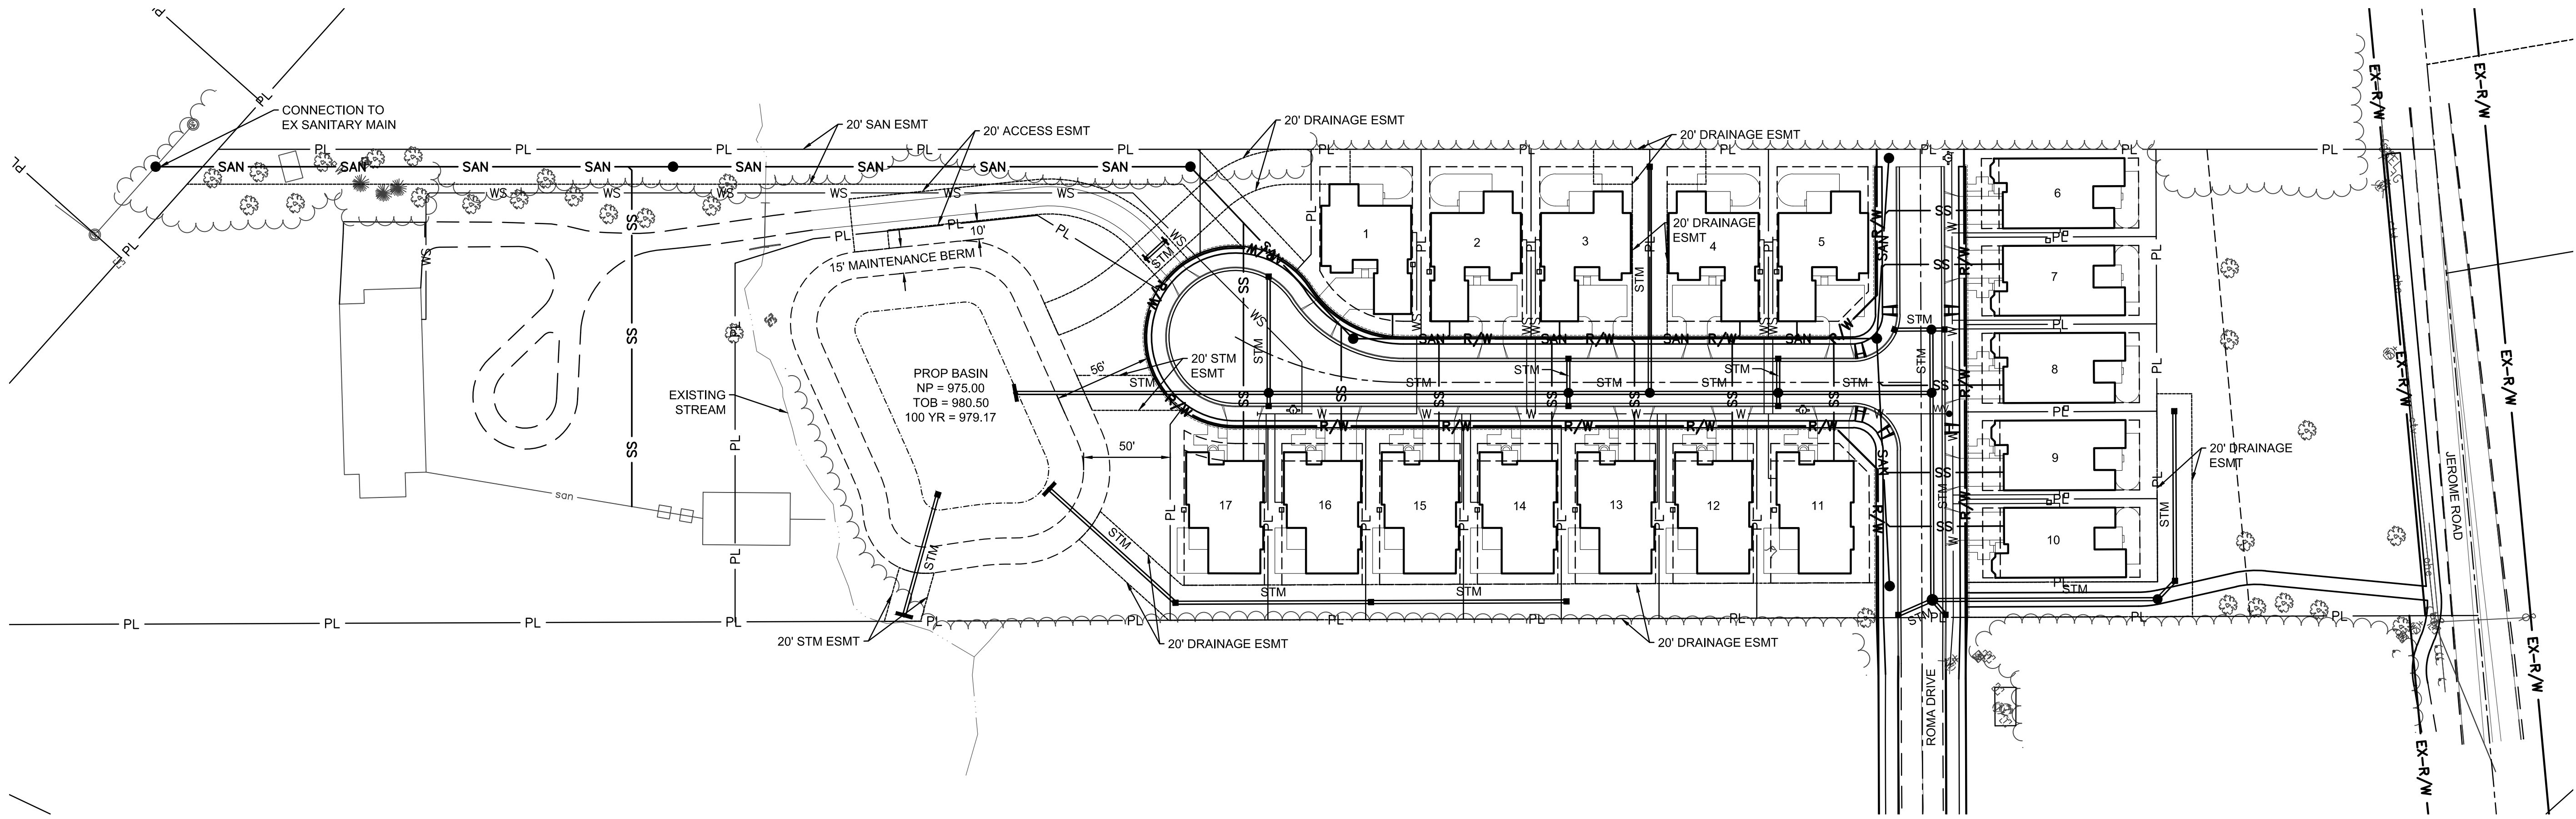

UTILITY LEGEND

- SAN** 8" SANITARY GRAVITY
- SS** SANITARY SERVICE
- W** WATER
- WS** DOMESTIC WATER SERVICE
- STM** STORM SEWER
- CATCH BASIN**
- HEADWALL**
- STORM MANHOLE**
- SANITARY MANHOLE**
- FIRE HYDRANT**
- WATER VALVE**

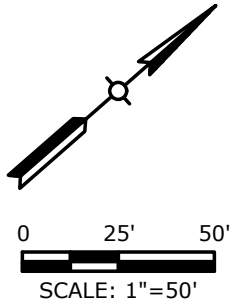

PUBLIC STREET, STORM, AND WATER
IMPROVEMENTS
FOR
HAMLET ON JEROME
CITY OF DUBLIN, DELAWARE COUNTY, OHIO
MASTER UTILITY PLAN

REVISIONS	DATE	SHEET NO.	DESCRIPTION	APPROVED	DATE

DATE:	07/19/2018
DRAWN BY:	MHS
CHECKED BY:	BJM
JOB NUMBER:	2017.01180

C1.0

AMERICAN STRUCTUREPOINT INC.
2550 Corporate Exchange Drive | Suite 300
Columbus, Ohio 43231
TEL 614.907.2235 | FAX 614.907.2236
www.structurepoint.com

The Hamlet on Jerome