
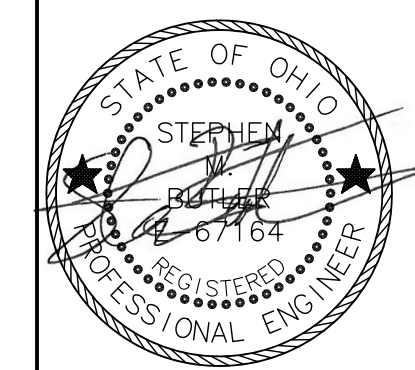


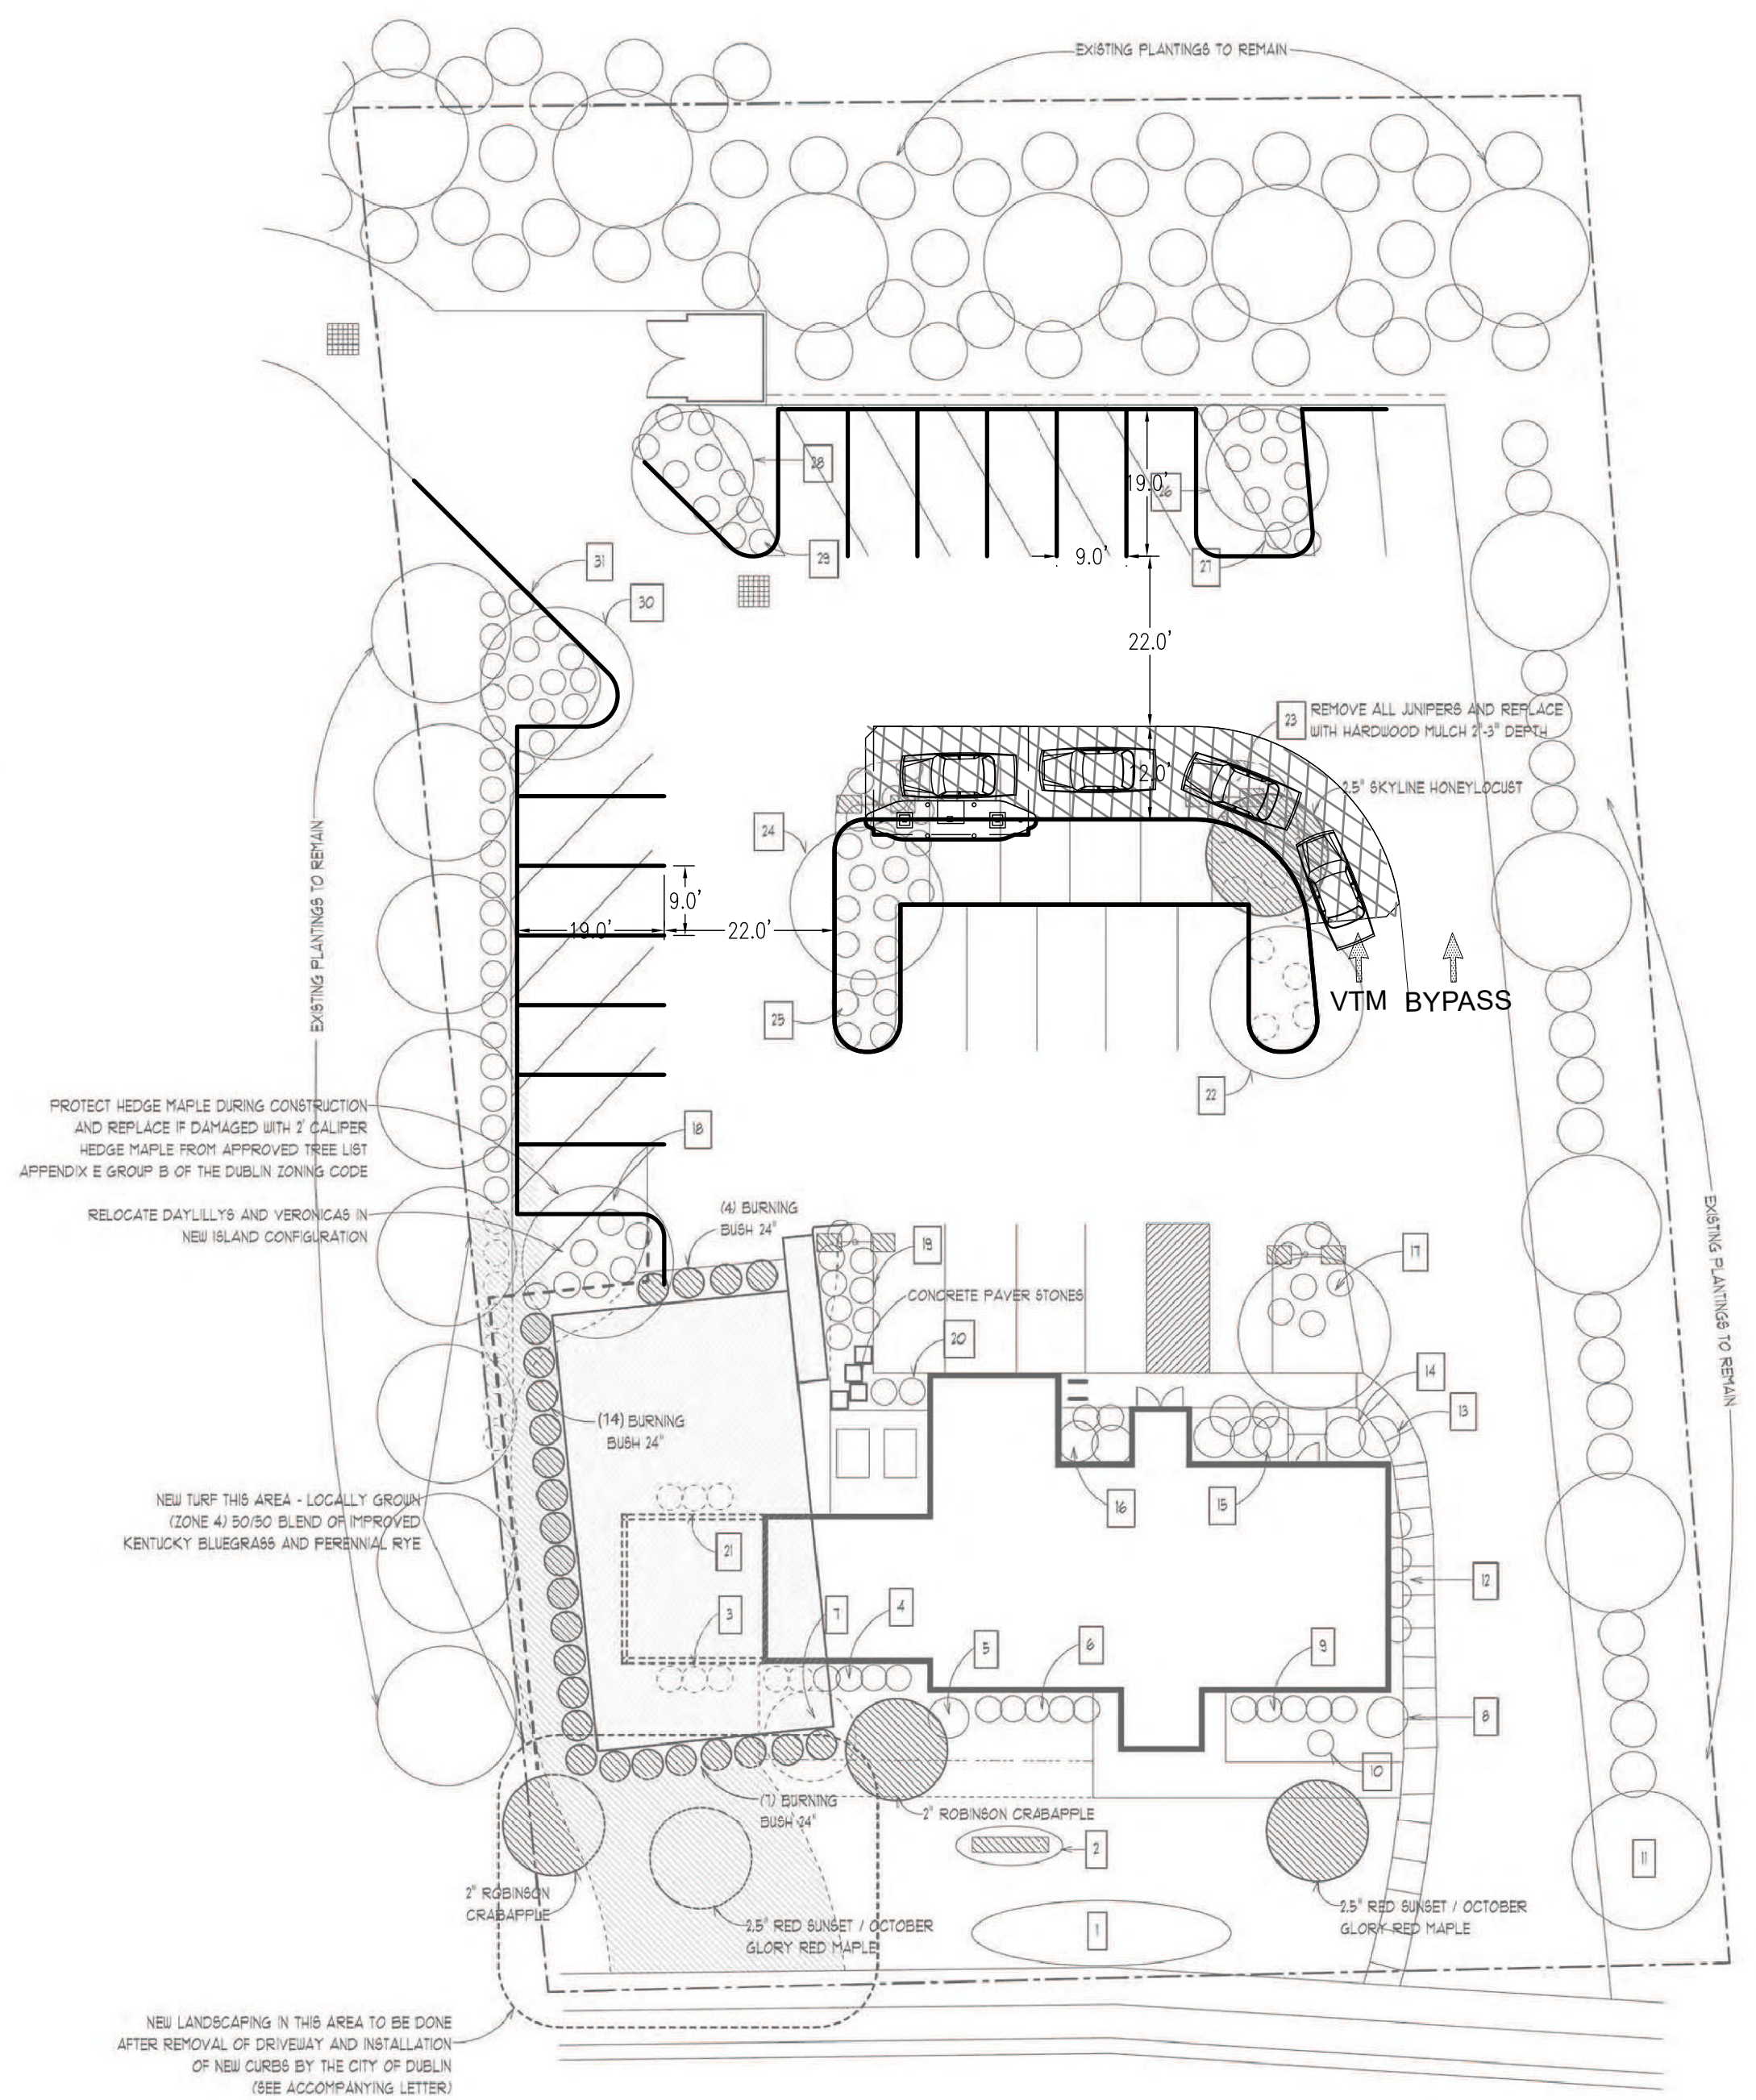

DESIGN: DATE: 09/12/2025
SMB
DRAWN:
CHECK:
JOB #: 25-604

CP3

CONCEPT SITE PLAN
Wright Patt Credit Union
48 CORBINS MILL DRIVE
CITY OF DUBLIN
FRANKLIN COUNTY, OHIO 43017

CCE
Community Civil Engineers, LLC
2440 DAYTON-XENIA ROAD, SUITE B
BEAVERCREEK, OHIO 45434
TEL. 937.490.9460 FAX 937.428.9798

Wright-Patt
CREDIT UNION, INC.
3560 Pentagon Blvd., Beavercreek, Ohio 45431
t: 937.912.8000 f: 937.912.8148

REVISIONS					
6					
5					
4					
3					
2					
1					