


**GENERAL NOTES**

- CONSTRUCTION SHALL COMPLY WITH ALL APPLICABLE LOCAL, STATE, AND NATIONAL CODES AND REGULATIONS.
- CONTRACTOR SHALL FIELD VERIFY ALL DIMENSIONS AND EXISTING CONDITIONS PRIOR TO BID TO DETERMINE THE EXTENT OF WORK. THE CONTRACTOR SHALL NOTIFY THE ARCHITECT OF ANY DISCREPANCIES PRIOR TO BIDDING.
- ALL EXISTING MATERIALS TO REMAIN WHICH ARE DAMAGED OR OTHERWISE DISTURBED BY THE CONTRACTOR'S OPERATIONS SHALL BE PATCHED OR REPAIRED TO MATCH THE EXISTING ADJACENT MATERIALS, SO THAT THE REPAIR IS IMPERCEPTIBLE.
- DURING THE COURSE OF CONSTRUCTION, IF THE CONTRACTOR UNCOVERS ANY CODE VIOLATION KNOWN TO HIM OR ANY DISCREPANCY WITH THE DESIGN, CONTRACTOR SHALL NOTIFY THE ARCHITECT OF SUCH IMMEDIATELY.
- CONTRACTOR SHALL ASSEMBLE AND INSTALL MATERIALS/ PRODUCTS IN STRICT ACCORDANCE WITH THE MANUF'S RECOMMENDATIONS AND INDUSTRIAL/ASSOCIATION STANDARDS.
- CONTACT ARCHITECT AND COORDINATE WITH TENANT ANY ADDITIONAL SPECIFICATIONS NOT SPECIFIED HEREIN AND/OR CLARIFICATIONS REGARDING THE CONTRACT DOCUMENTS.
- NO CURRENT SURVEY WAS PERFORMED. THE CONTRACTOR SHALL NOTIFY THE ENGINEER IMMEDIATELY, IN WRITING, OF ANY DISCREPANCIES OR OMISSIONS TO THE TOPOGRAPHIC INFORMATION. THE CONTRACTOR(S) SHALL BE RESPONSIBLE FOR CONFIRMING THE LOCATION (HORIZONTAL/VERTICAL) OF ANY BURIED CABLES, CONDUITS, PIPES, AND STRUCTURES (STORM SEWER, SANITARY SEWER, WATER, GAS, TELEVISION, TELEPHONE, ETC.) WHICH IMPACT THE CONSTRUCTION SITE. THE CONTRACTOR(S) SHALL NOTIFY THE OWNER AND ENGINEER IN WRITING IF ANY DISCREPANCIES ARE FOUND BETWEEN THE ACTUAL CONDITIONS VERSUS THE DATA CONTAINED IN THE CONSTRUCTION PLANS. ANY COSTS INCURRED AS THE RESULT OF NOT CONFIRMING THE ACTUAL LOCATION (HORIZONTAL/VERTICAL) OF SAID CABLES, CONDUITS, PIPES, AND STRUCTURES SHALL BE BORNE BY THE CONTRACTOR. ADDITIONALLY, THE CONTRACTOR(S) SHALL NOTIFY THE OWNER AND ENGINEER IN WRITING IF ANY ERRORS OR DISCREPANCIES ARE FOUND ON THE CONSTRUCTION DOCUMENTS (PS&E), WHICH NEGATIVELY IMPACT THE PROJECT. THE ENGINEER AND OWNER SHALL BE INDEMNIFIED OF PROBLEMS AND/OR COST WHICH MAY RESULT FROM THE CONTRACTOR'S FAILURE TO NOTIFY THE ENGINEER AND OWNER.
- IT IS STRONGLY RECOMMENDED THAT NO CONTRACTUAL AGREEMENT OF ANY KIND BE SIGNED PRIOR TO RECEIVING AND THOROUGHLY REVIEWING ALL APPROVALS FROM ALL OF THE REGULATORY AUTHORITIES HAVING JURISDICTION OVER THIS PROJECT.


**BUILDING CODE SUMMARY**

APPLICABLE BUILDING CODE: 2017 OHIO BUILDING CODE  
 APPLICABLE ELECTRICAL CODE: NATIONAL ELECTRICAL CODE, 2017 EDITION  
 USE GROUP: A2 - ASSEMBLY  
 BUILDING DEPARTMENT PHONE NO: (614)-410-4670  
 EXISTING SIGNAGE AREA TO BE REMOVED: 54 SQ FT  
 NEW SIGNAGE AREA TO BE ADDED: 30.25 SQ FT  
 PROJECT ADDRESS: 6850 HOSPITAL DR DUBLIN, OH 43016

**VICINITY MAP (NTS)**

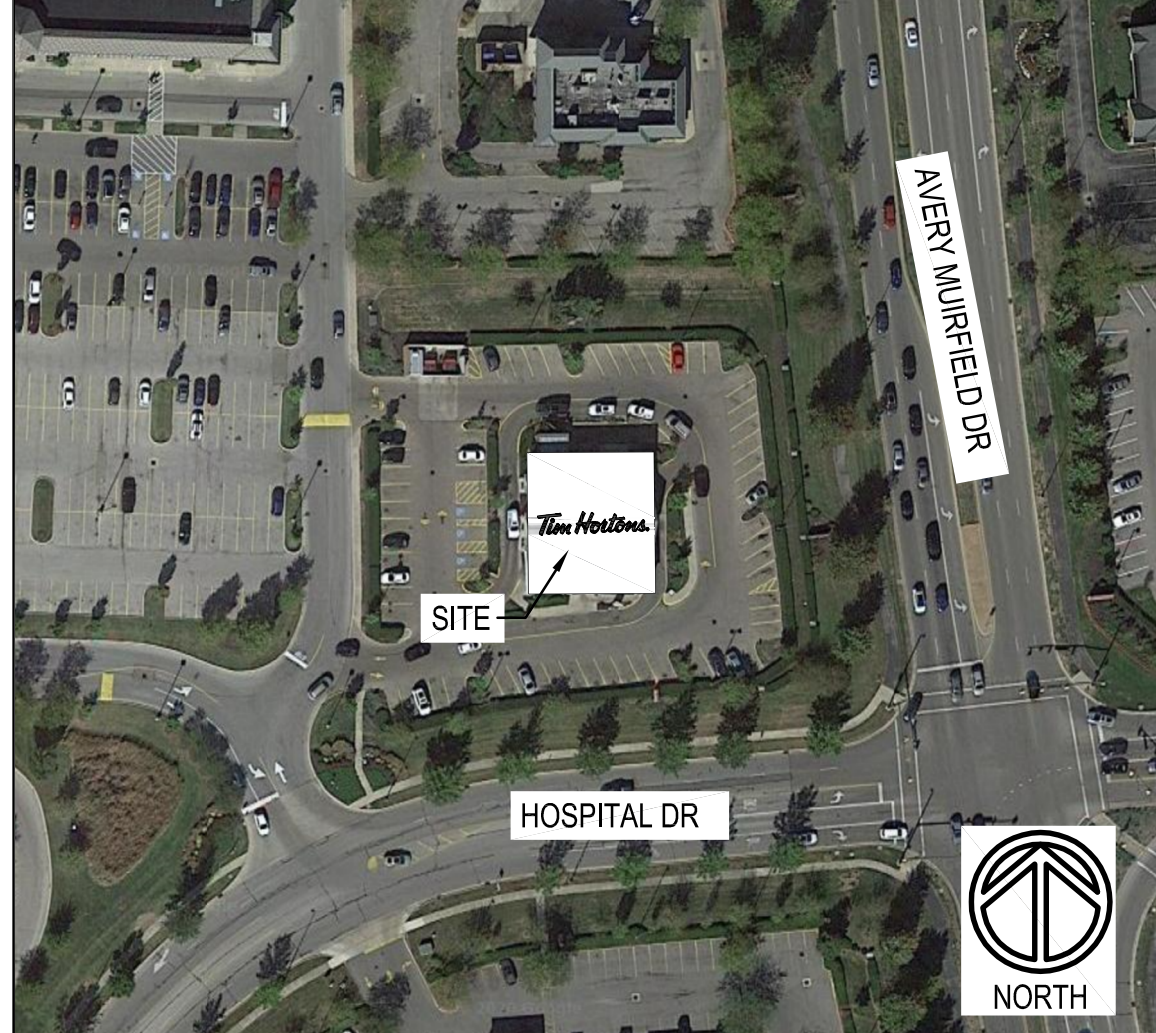

PRE-BROWSE  
7.64 SQ FT

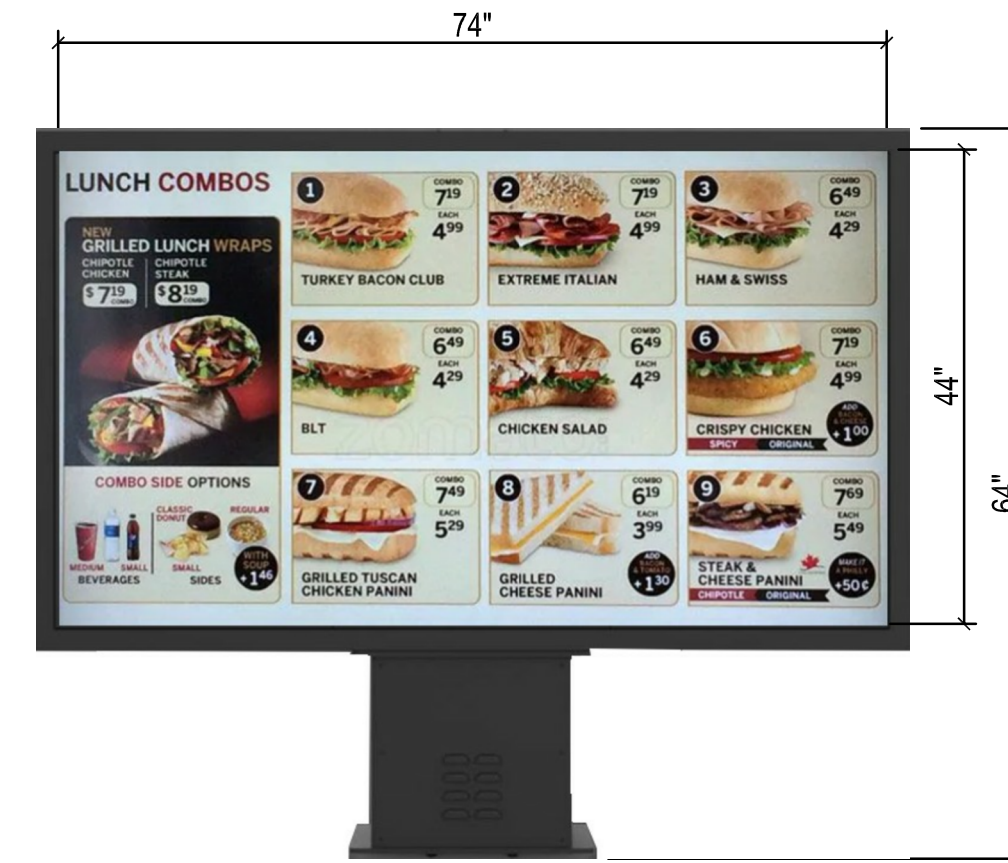

THREE PANEL MENU BOARD  
22.61 SQ FT



SIDE VIEW

**NEW MENU BOARDS AND PRE-BROWSE BOARDS**

NOT TO SCALE

**SITE NOTES**

- ALL DIMENSIONS SHOWN ARE TO FACE OF CURB UNLESS NOTED OTHERWISE.
- BASES, ANCHOR BOLTS, CONDUIT, AND WIRING FOR ALL SIGNS ARE BY THE GENERAL CONTRACTOR.
- EXISTING MENU BOARDS AND PRE-SALE BOARDS TO BE REMOVED FROM BASES, REMOVED FROM SITE, AND DISPOSED UNLESS DIRECTED BY BAILIWK. CONDUITS TO BE CAPPED TO PREVENT MOISTURE ENTRANCE.

**UTILITY NOTES**

- ALL ELECTRICAL/CONDUIT RUNS ARE SCHEMATIC ONLY. CONDUIT SIZES AND ROUTING PROVIDED BY BAILIWK.
- IT SHALL BE THE SIGN INSTALLER'S RESPONSIBILITY TO ENSURE THE PROPOSED SIGN LOCATION DOES NOT INTERFERE WITH ANY UTILITIES AND COMPLIES WITH ALL APPLICABLE CITY CODES. SIGN INSTALLER SHALL ALSO OBTAIN APPROVAL FROM THE APPROPRIATE ENTITIES PRIOR TO INSTALLING THE SIGN OVER ANY EXISTING EASEMENTS.
- REFER TO THE BUILDING ELECTRICAL DRAWINGS FOR UTILITY SERVICE ENTRANCE LOCATIONS, SIZES, AND CIRCUITING.

**DEMOLITION NOTES**

- CONTRACTOR IS RESPONSIBLE FOR THE REPAIR OF ANY DAMAGE TO EXISTING IMPROVEMENTS DURING CONSTRUCTION, SUCH AS, BUT NOT LIMITED TO: DRAINAGE, UTILITIES, PAVEMENT, STRIPING, CURB, ETC. REPAIRS SHALL BE EQUAL TO OR BETTER THAN EXISTING CONDITIONS.
- ALL WORK ON THIS PLAN SHALL BE DONE IN STRICT ACCORDANCE WITH SITE WORK SPECIFICATIONS.
- CONTRACTOR SHALL COMPLY TO THE FULLEST EXTENT WITH THE LATEST STANDARDS OF OSHA DIRECTIVES OR ANY OTHER AGENCY HAVING JURISDICTION FOR EXCAVATION AND TRENCHING PROCEDURE. CONTRACTOR SHALL USE SUPPORT SYSTEMS, SLOPING, BENCHING, OR OTHER MEANS OF PROTECTION, INCLUDING BUT IS NOT LIMITED TO, ACCESS AND EGRESS FROM ALL EXCAVATION AND TRENCHING. CONTRACTOR IS RESPONSIBLE TO COMPLY WITH PERFORMANCE CRITERIA FOR OSHA.
- CONTRACTOR SHALL BE RESPONSIBLE FOR PROTECTING THE PUBLIC DURING CONSTRUCTION, INCLUDING BUT NOT LIMITED TO: CONSTRUCTION FENCING, BARRICADES, SIGNAGE, ETC.
- CONTRACTOR IS RESPONSIBLE FOR VERIFYING ALL UTILITIES AND NOTIFYING THE APPROPRIATE UTILITY COMPANY PRIOR TO BEGINNING CONSTRUCTION.
- CONTRACTOR SHALL VERIFY HORIZONTAL AND VERTICAL LOCATION OF ALL EXISTING UTILITIES PRIOR TO CONSTRUCTION.

**SCOPE OF WORK**

REMOVE EXISTING MENU BOARDS AND CAP CONDUIT PER SITE NOTES. INSTALL NEW MENU BOARDS AND ALL REQUIRED CONDUIT AND WIRING. REFER TO MANUFACTURERS BOARD PUBLISHED INSTALLATION INSTRUCTIONS.




SINGLE FACE  
4-PANEL  
33 SQ FT



SINGLE FACE  
PRE-BROWSE  
21 SQ FT

**EXISTING MENU BOARDS TO BE REMOVED**

NOT TO SCALE

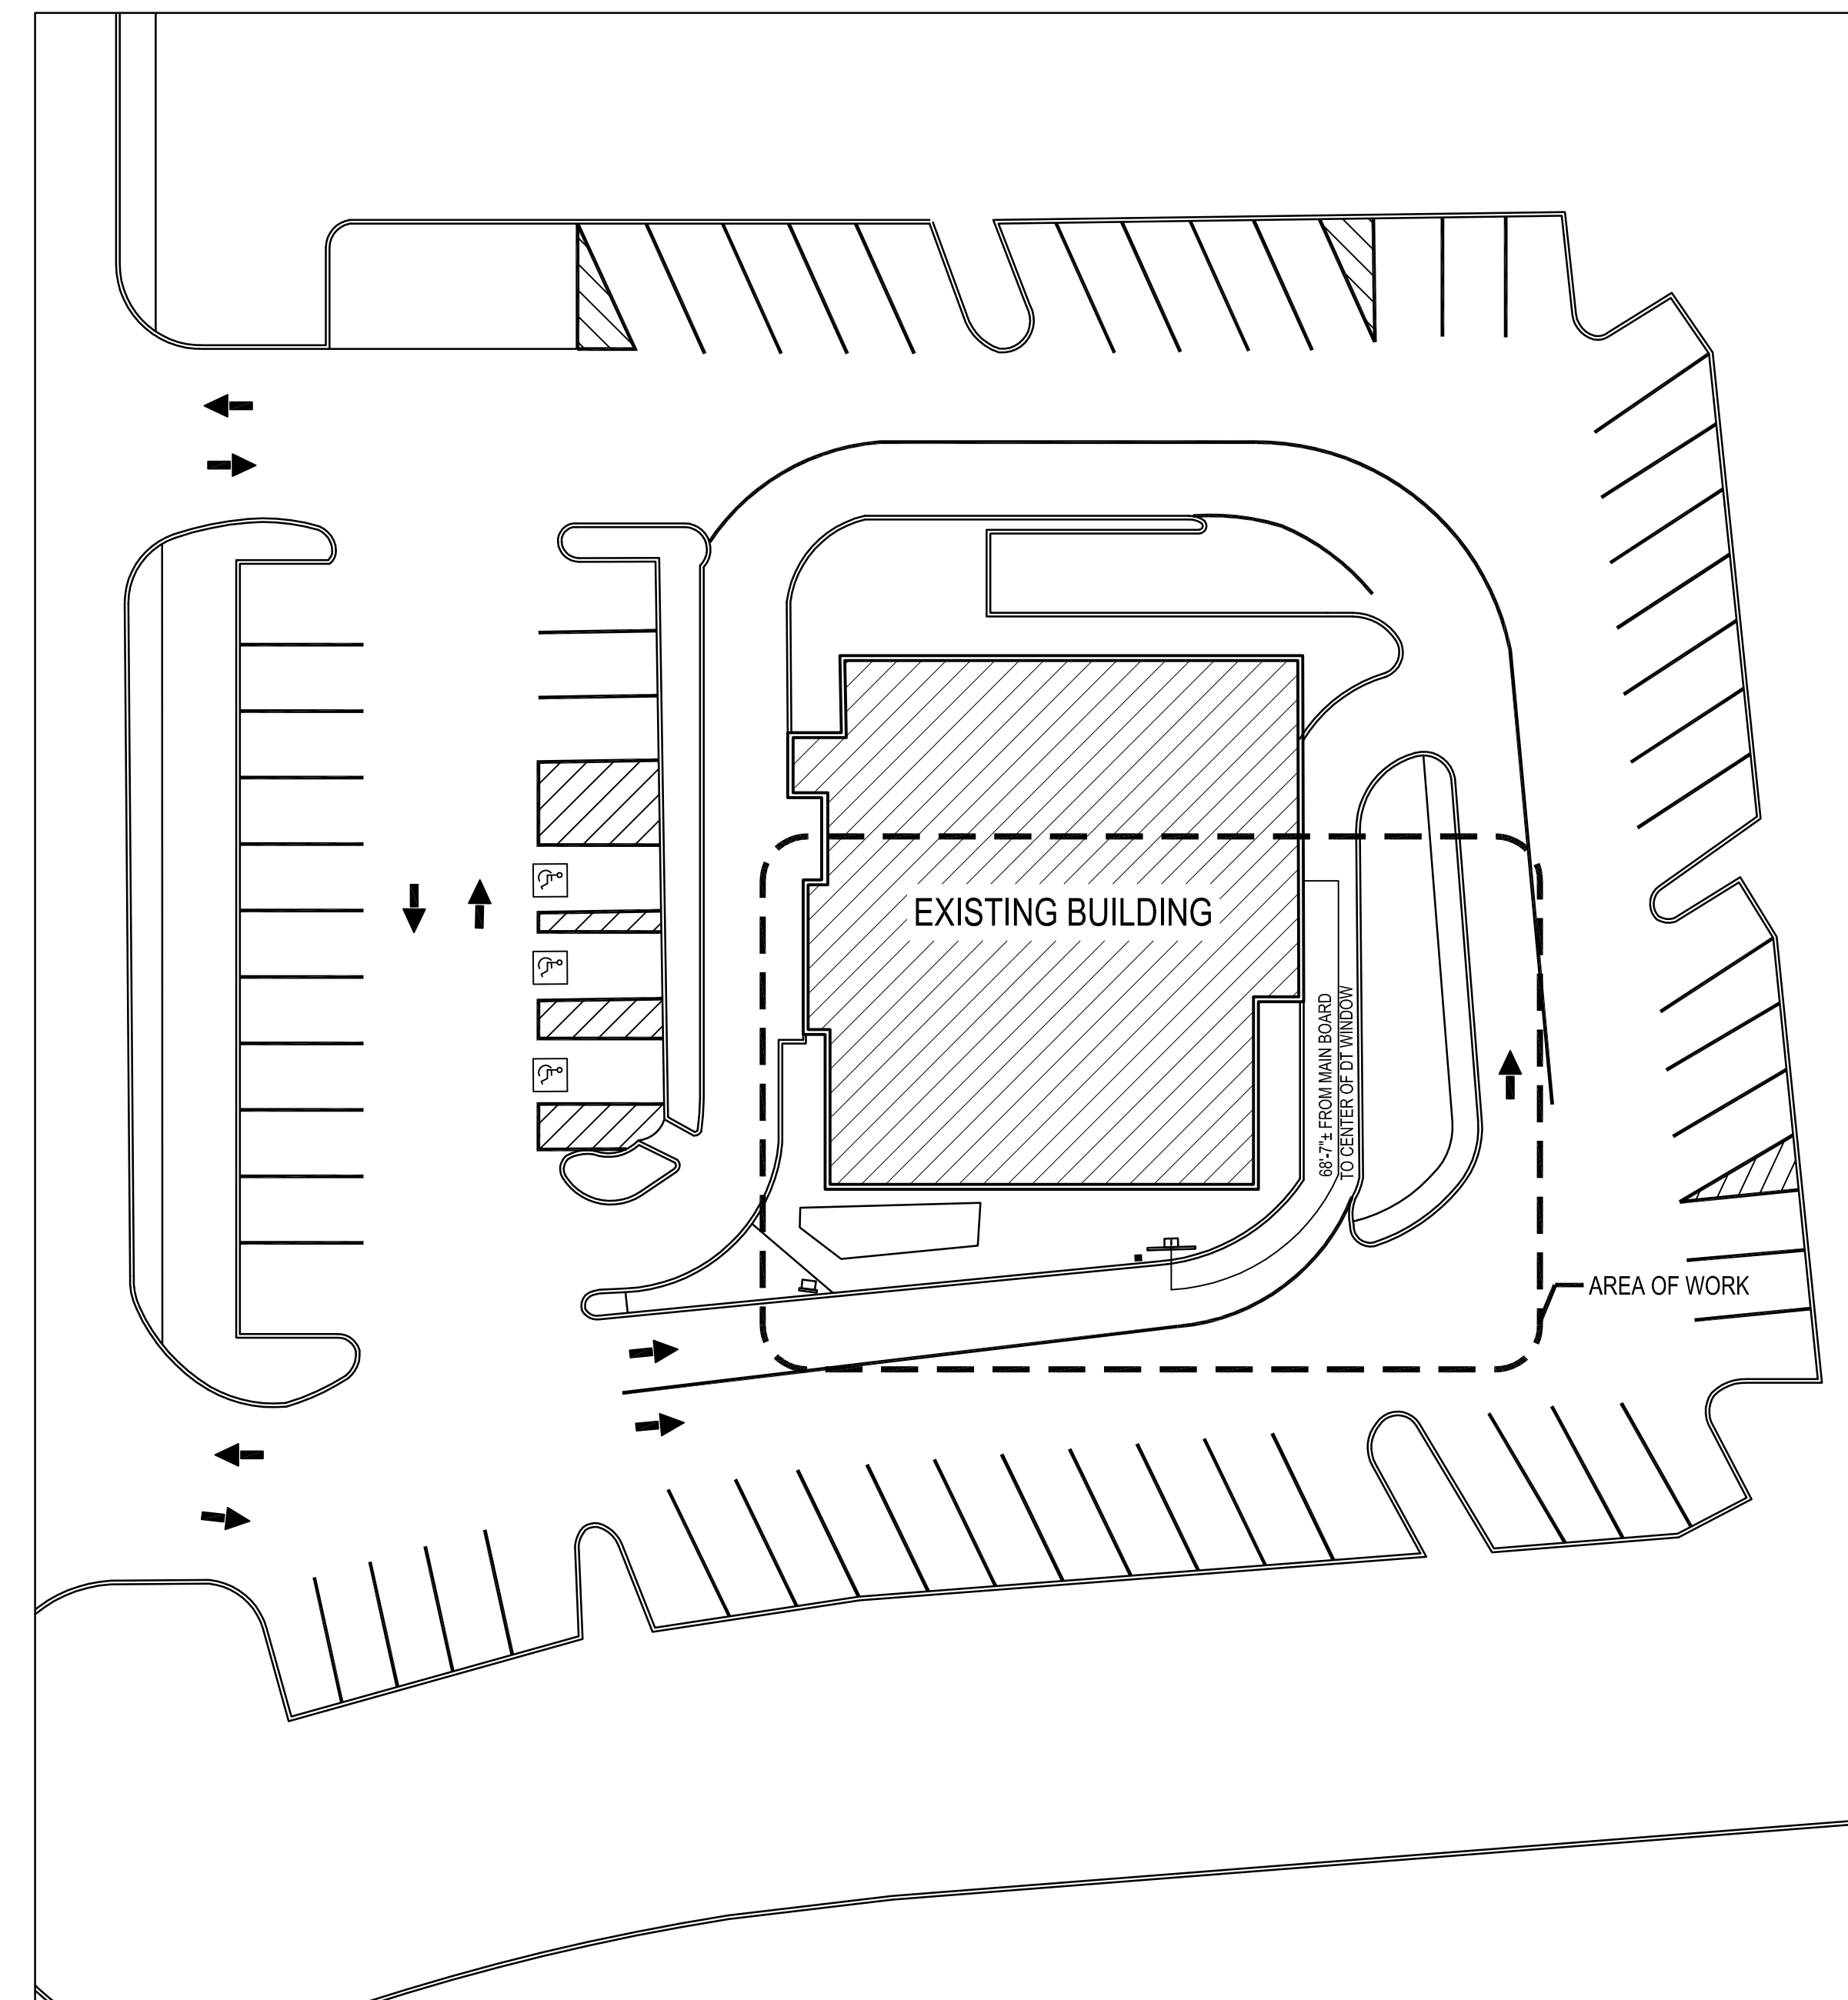

**EXISTING OVERALL SITE PLAN**

SCALE: 1" = 20'-0"





REV	DATE	BY	DESCRIPTION



**RRMM ARCHITECTS, PC**

1317 Executive Blvd, Suite 200  
Chesapeake, VA 23320  
(757) 622-2828 / fax (757) 622-6883

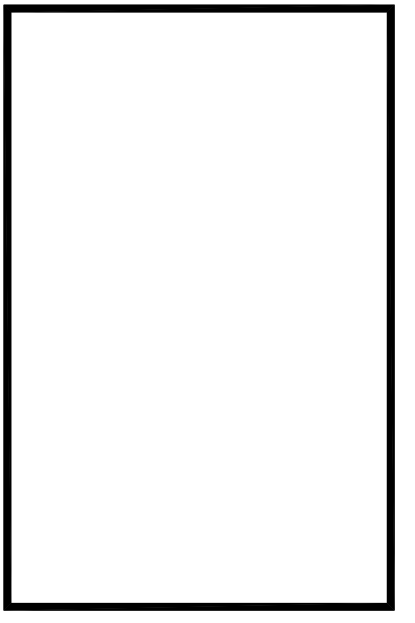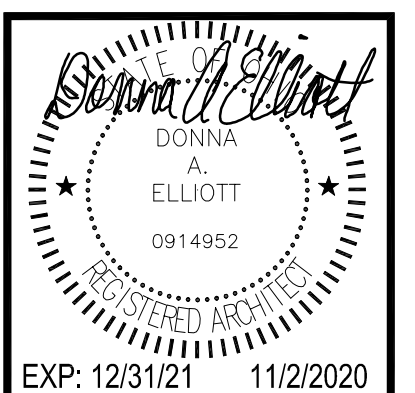


**Tim Hortons**  
 THS 9934845  
 SITE ADDRESS: 6850 HOSPITAL DR., DUBLIN, OH 43016

DATE	10/30/2020
PROJECT	20800-08
DESIGNED	SBG
DRAWN	SLG
CHECKED	DAE

**SITE PLAN AND NOTES**

**C1.0**

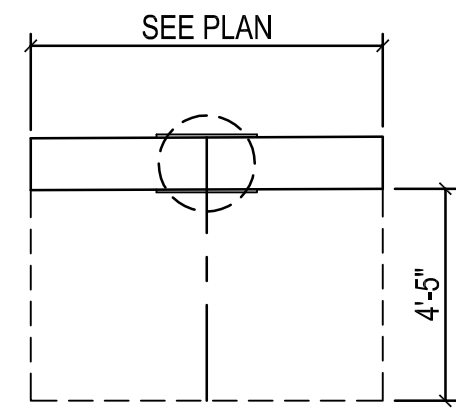

**ENLARGED TRIPLE PANEL BOARD PLAN**  
SCALE 1/4"=1'-0" SEE C1.0 FOR BOARD TYPES

**SITE PLAN KEY NOTES**

- 1 EXISTING MENU BOARD TO BE REMOVED. SEE SITE NOTE #3.
- 2 EXISTING SPEAKER TO BE REMOVED. SEE SITE NOTE #3.
- 3 EXISTING PRE-SELL BOARD TO BE REMOVED. SEE SITE NOTE #3.
- 4 NEW TRIPLE PANEL MENU BOARD. REFER TO STRUCTURAL SHEET FOR FOOTING INFORMATION.
- 5 HME SPEAKER POST REFER TO STRUCTURAL FOR FOOTING INFORMATION.
- 6 NEW SINGLE PANEL PRE-SELL BOARD. REFER TO STRUCTURAL SHEET FOR FOOTING INFORMATION.

**SITE PLAN LEGEND**

- EXISTING MENU BOARD TO BE REMOVED
- EXISTING SPEAKER TO BE REMOVED
- EXISTING PRE-SELL BOARD TO BE REMOVED
- NEW TRIPLE PANEL OUTDOOR DIGITAL MENU BOARD
- ORDER POINT/SPEAKER POST (INSTALLED BY OTHERS)
- NEW SINGLE PANEL OUTDOOR DIGITAL PRE-SELL BOARD

**ELECTRICAL PLAN NOTES**

1. INTENT OF DESIGN: DISCONNECT POWER AND DATA FEEDS FROM EXISTING MENU BARDS AND PRE-SALE BOARDS, REMOVE AND DISPOSE.
2. CONTRACTORS ARE TO INSTALL NEW CONDUIT, ELECTRICAL WIRE AND DATA CABLE.
3. NOTED CIRCUIT NUMBERS DERIVED FROM EXISTING PANEL DIRECTORY INSERTS. CONTRACTOR TO FIELD VERIFY AND UTILIZE EXISTING BRANCH CIRCUITS FEEDING THE PRIMARY (BRANCH CIRCUIT 1) AND SECONDARY (BRANCH CIRCUIT 2) MENU BOARDS AND PRE-BROWSE BOARDS.
4. COORDINATE ALL CONDUIT AND CIRCUITING SIZE REQUIREMENTS WITH MANUFACTURERS INSTALL REQUIREMENTS
5. ALL NEW PULLBOXES / HANDHOLDS SHALL BE A MINIMUM OF TIER 8 QUAZITES BOX OR APPROVED EQUAL.
6. PROVIDE DEDICATED NEUTRAL FOR ALL CIRCUITS, NO SHARED NEUTRALS ALLOWED.


**CONDUIT PLAN KEY NOTES**

- 1 ONE 3/4" PVC CONDUIT (4-#12, 1-#12 GRD, 1-#12 IG) FROM PANEL CP TO J-BOX
- 2 ONE 3/4" PVC CONDUIT (2-#12, 1-#12 GRD, 1-#12 IG) FROM J-BOX TO NEW MAIN MENU BOARD
- 3 ONE 3/4" PVC CONDUIT (2-#12, 1-#12 GRD, 1-#12 IG) FROM J-BOX TO NEW PRE-SELL BOARD
- 4 ONE 2" PVC CONDUIT (CAT6 DATA CABLES) FROM BUILDING TO J-BOX
- 5 ONE 2" PVC CONDUIT (CAT6 DATA CABLES) FROM J-BOX TO MENU BOARD
- 6 ONE 2" PVC CONDUIT (CAT6 DATA CABLES) FROM J-BOX TO PRE-SALE BOARD
- 7 ONE 3/4" PVC CONDUIT (SPEAKER WIRE) FROM J-BOX TO NEW SPEAKER LOCATION


REV	DATE	BY	DESCRIPTION

**RRMM ARCHITECTS, PC**  
1317 Executive Blvd, Suite 200  
Chesapeake, VA 23320  
(757) 622-2828 / fax (757) 622-6883

*Donna A. Elliott*  
DONNA A. ELLIOTT  
0914952  
REGISTERED ARCHITECT  
EXP: 12/31/21 11/2/2020

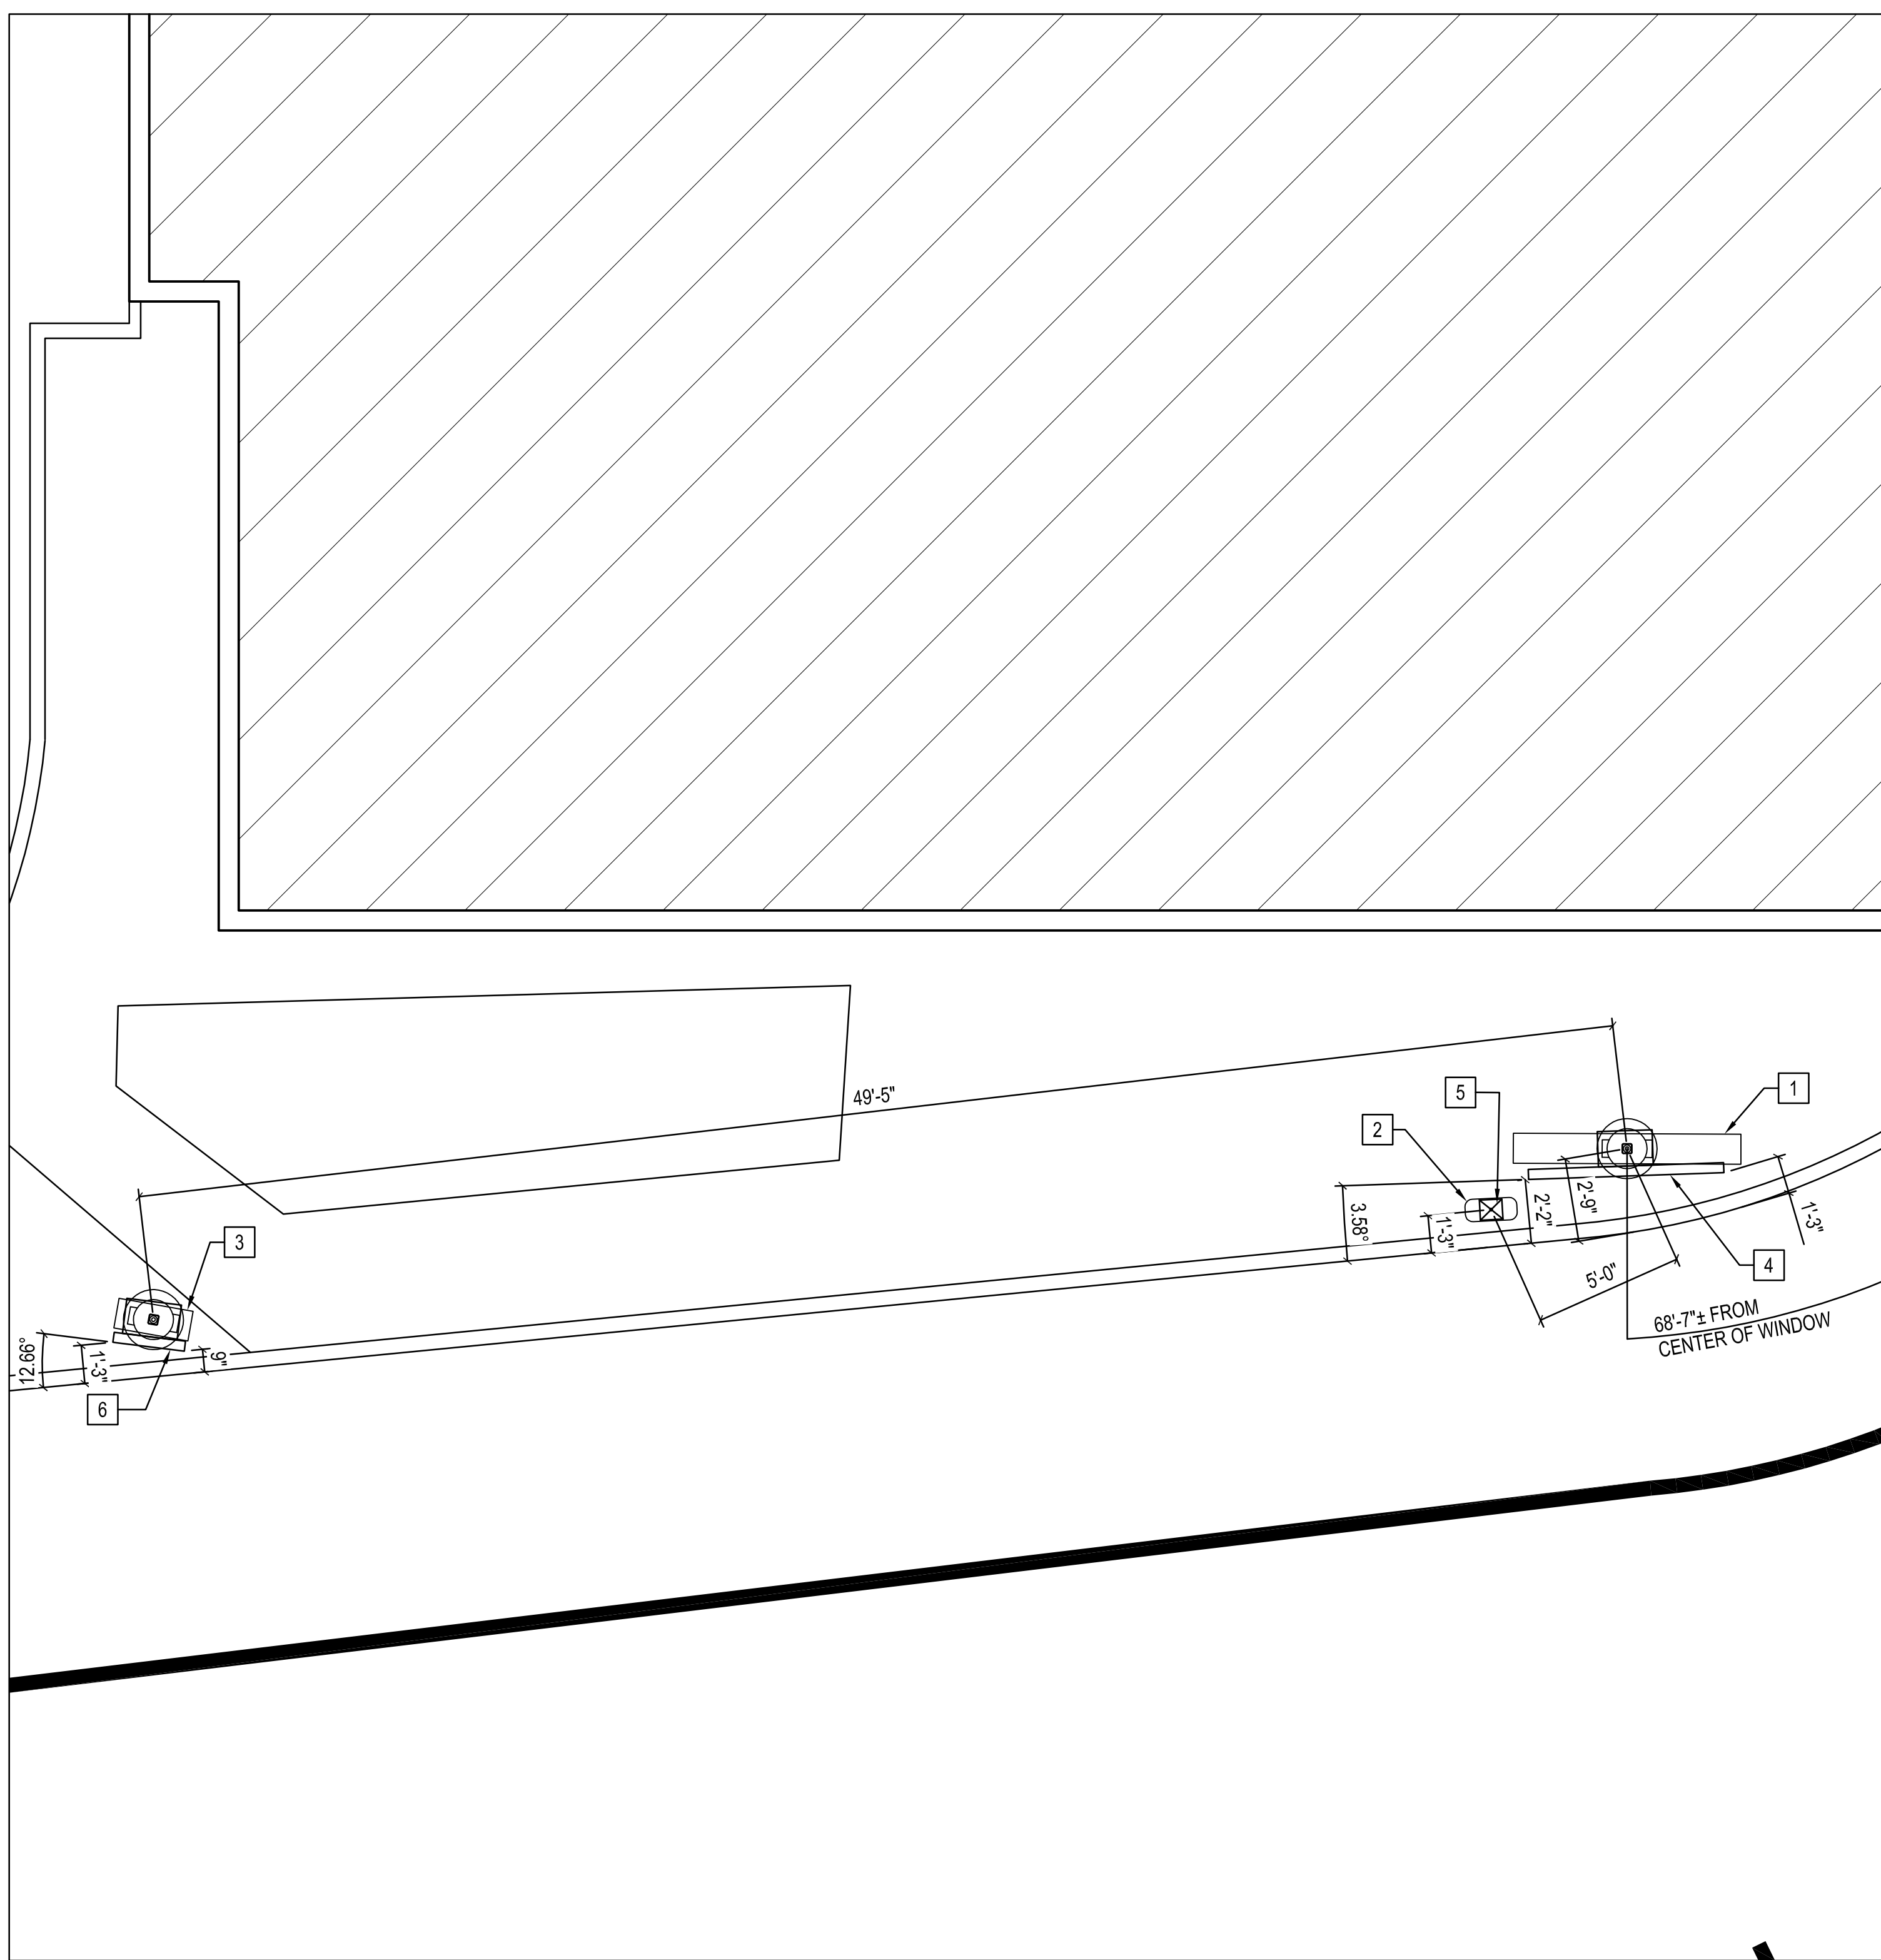

**ENLARGED SITE PLAN**  
SCALE: 1/4" = 1'-0"

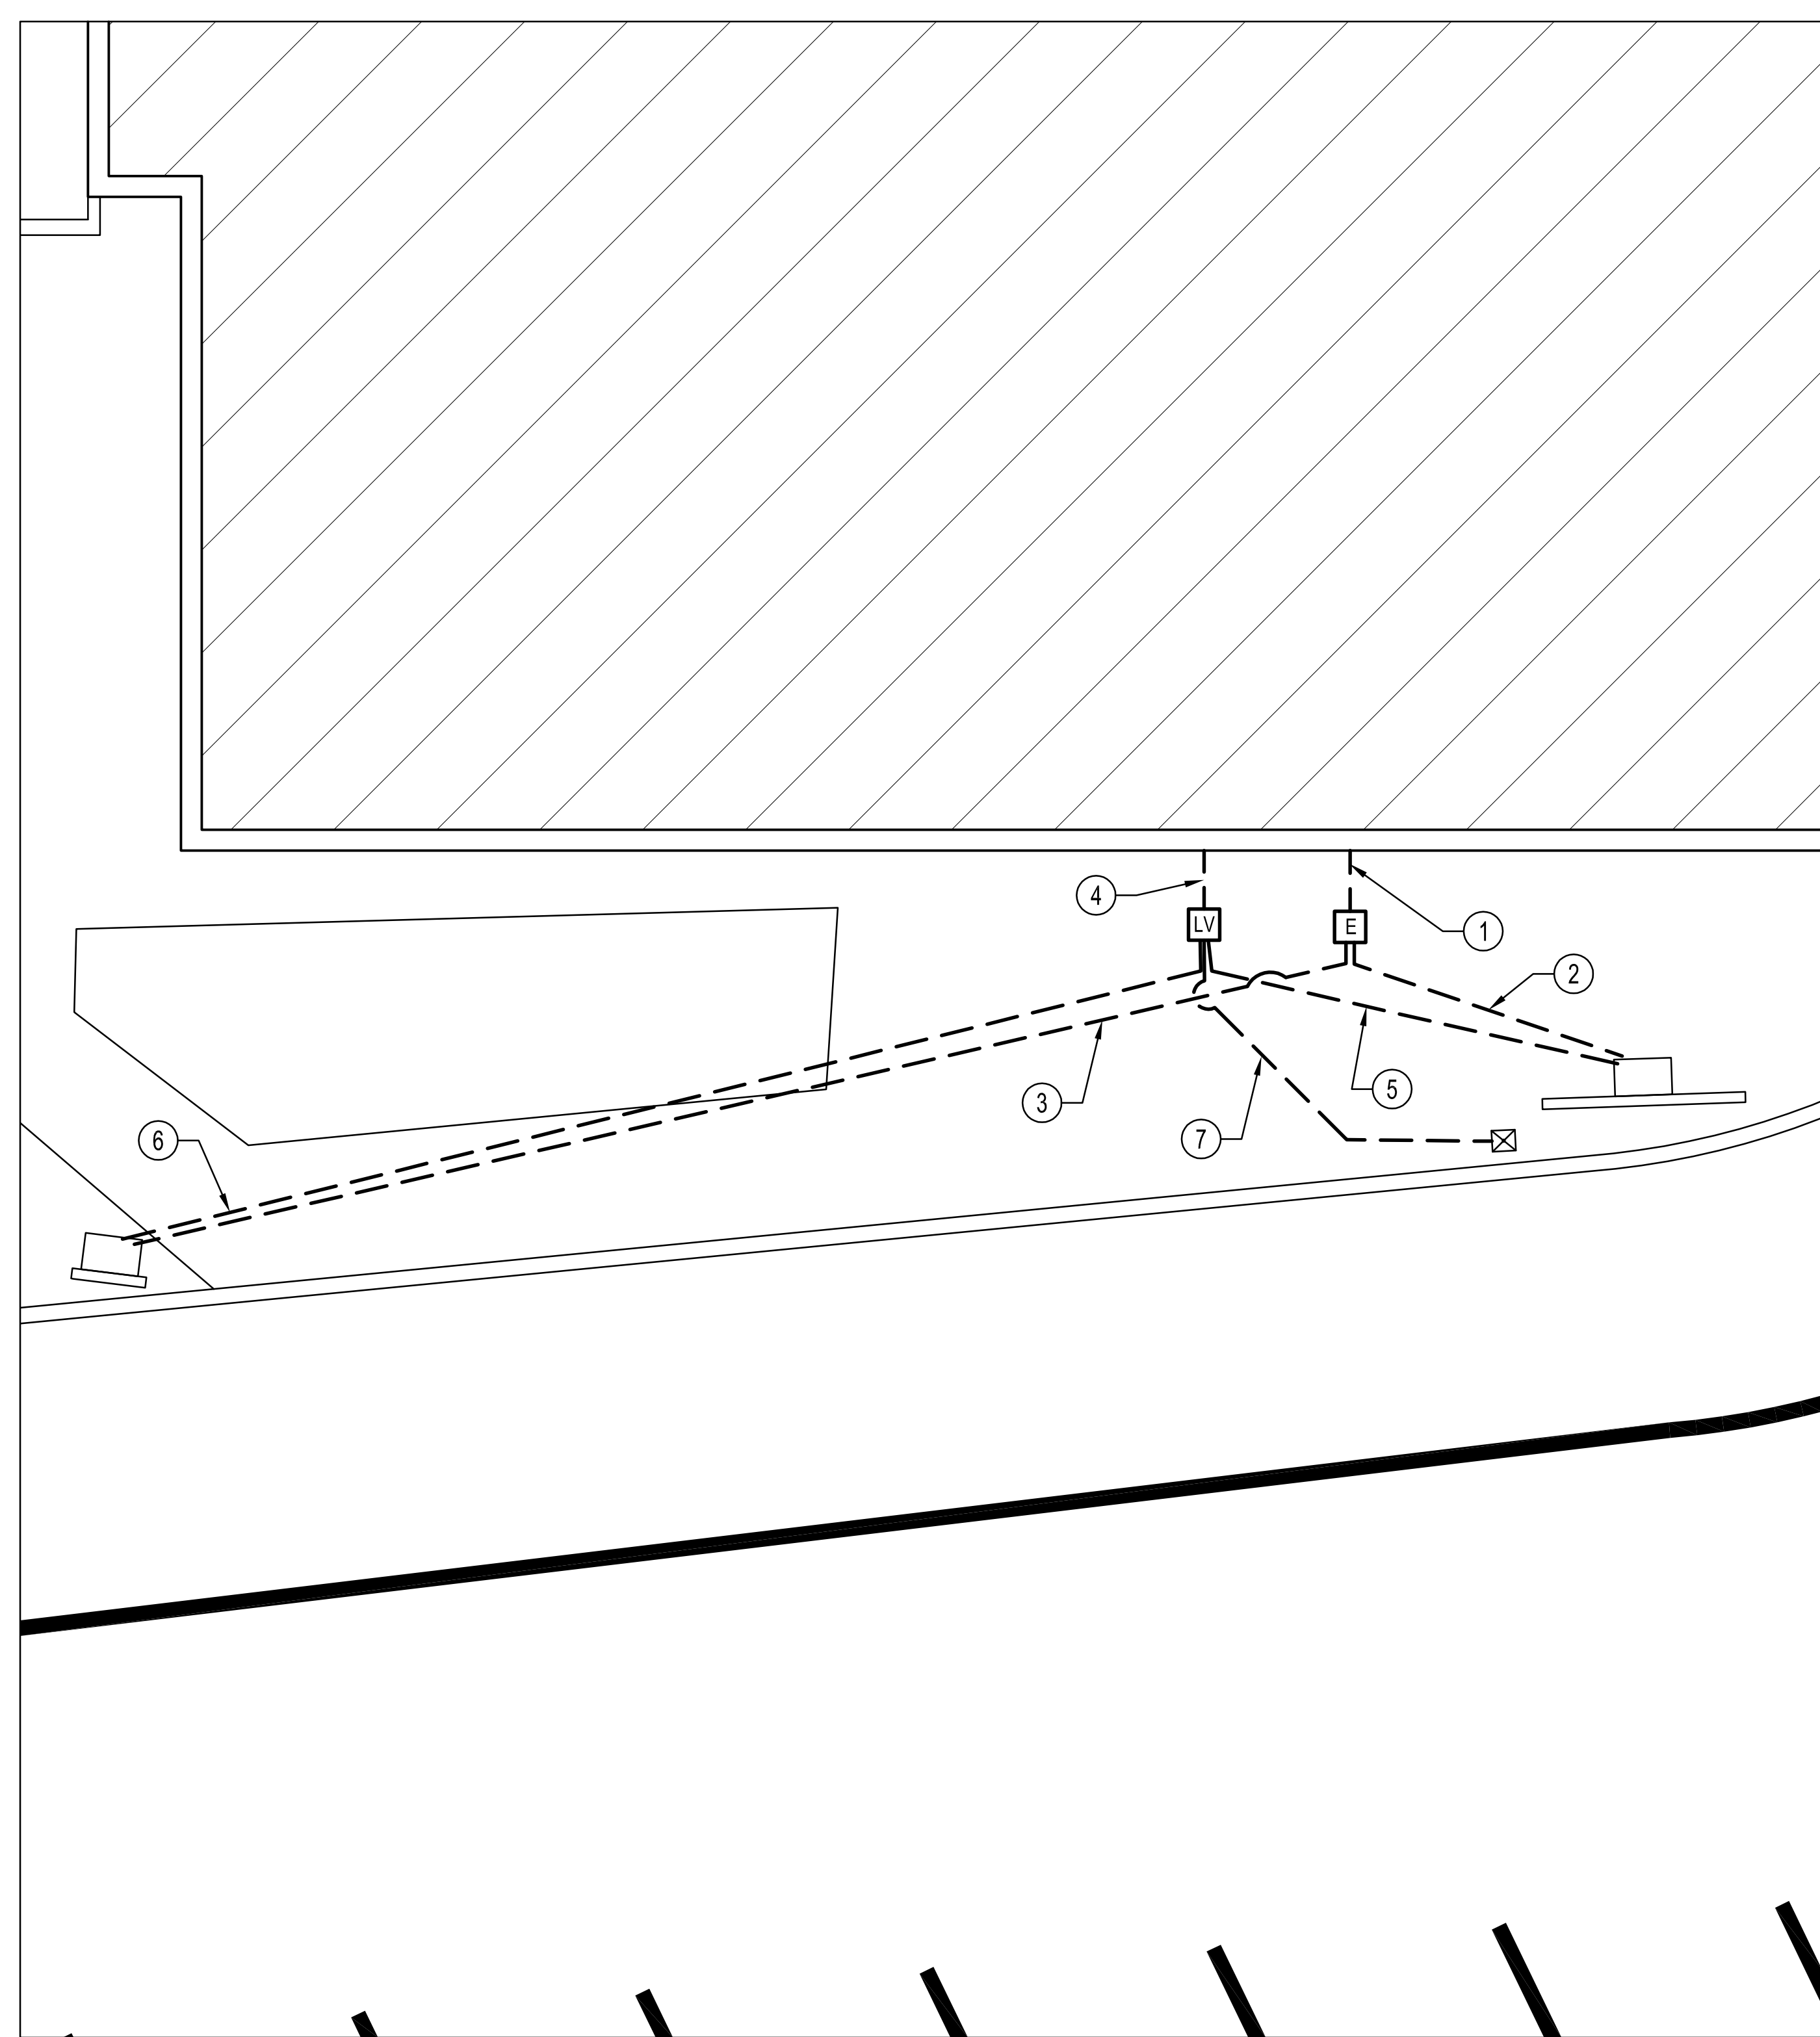

**ENLARGED CONDUIT PLAN**  
SCALE: 1/4" = 1'-0"



FILE NAME: C:\Users\jgheeta\appdata\local\temp\pdpublish\_1737228090\66A\_C1\_1.dwg LAYOUT NAME: Work PLOTTED: Monday, November 02, 2020, 10:10am

**Tim Houtons.** THS 915741  
SITE ADDRESS: 6850 HOSPITAL DR  
DUBLIN, OH 43016

DATE	10/30/2020
PROJECT	20800-65
DESIGNED	SLG
DRAWN	SLG
CHECKED	DAE

**ENLARGED UTILITY PLANS**  
**C1.1**